



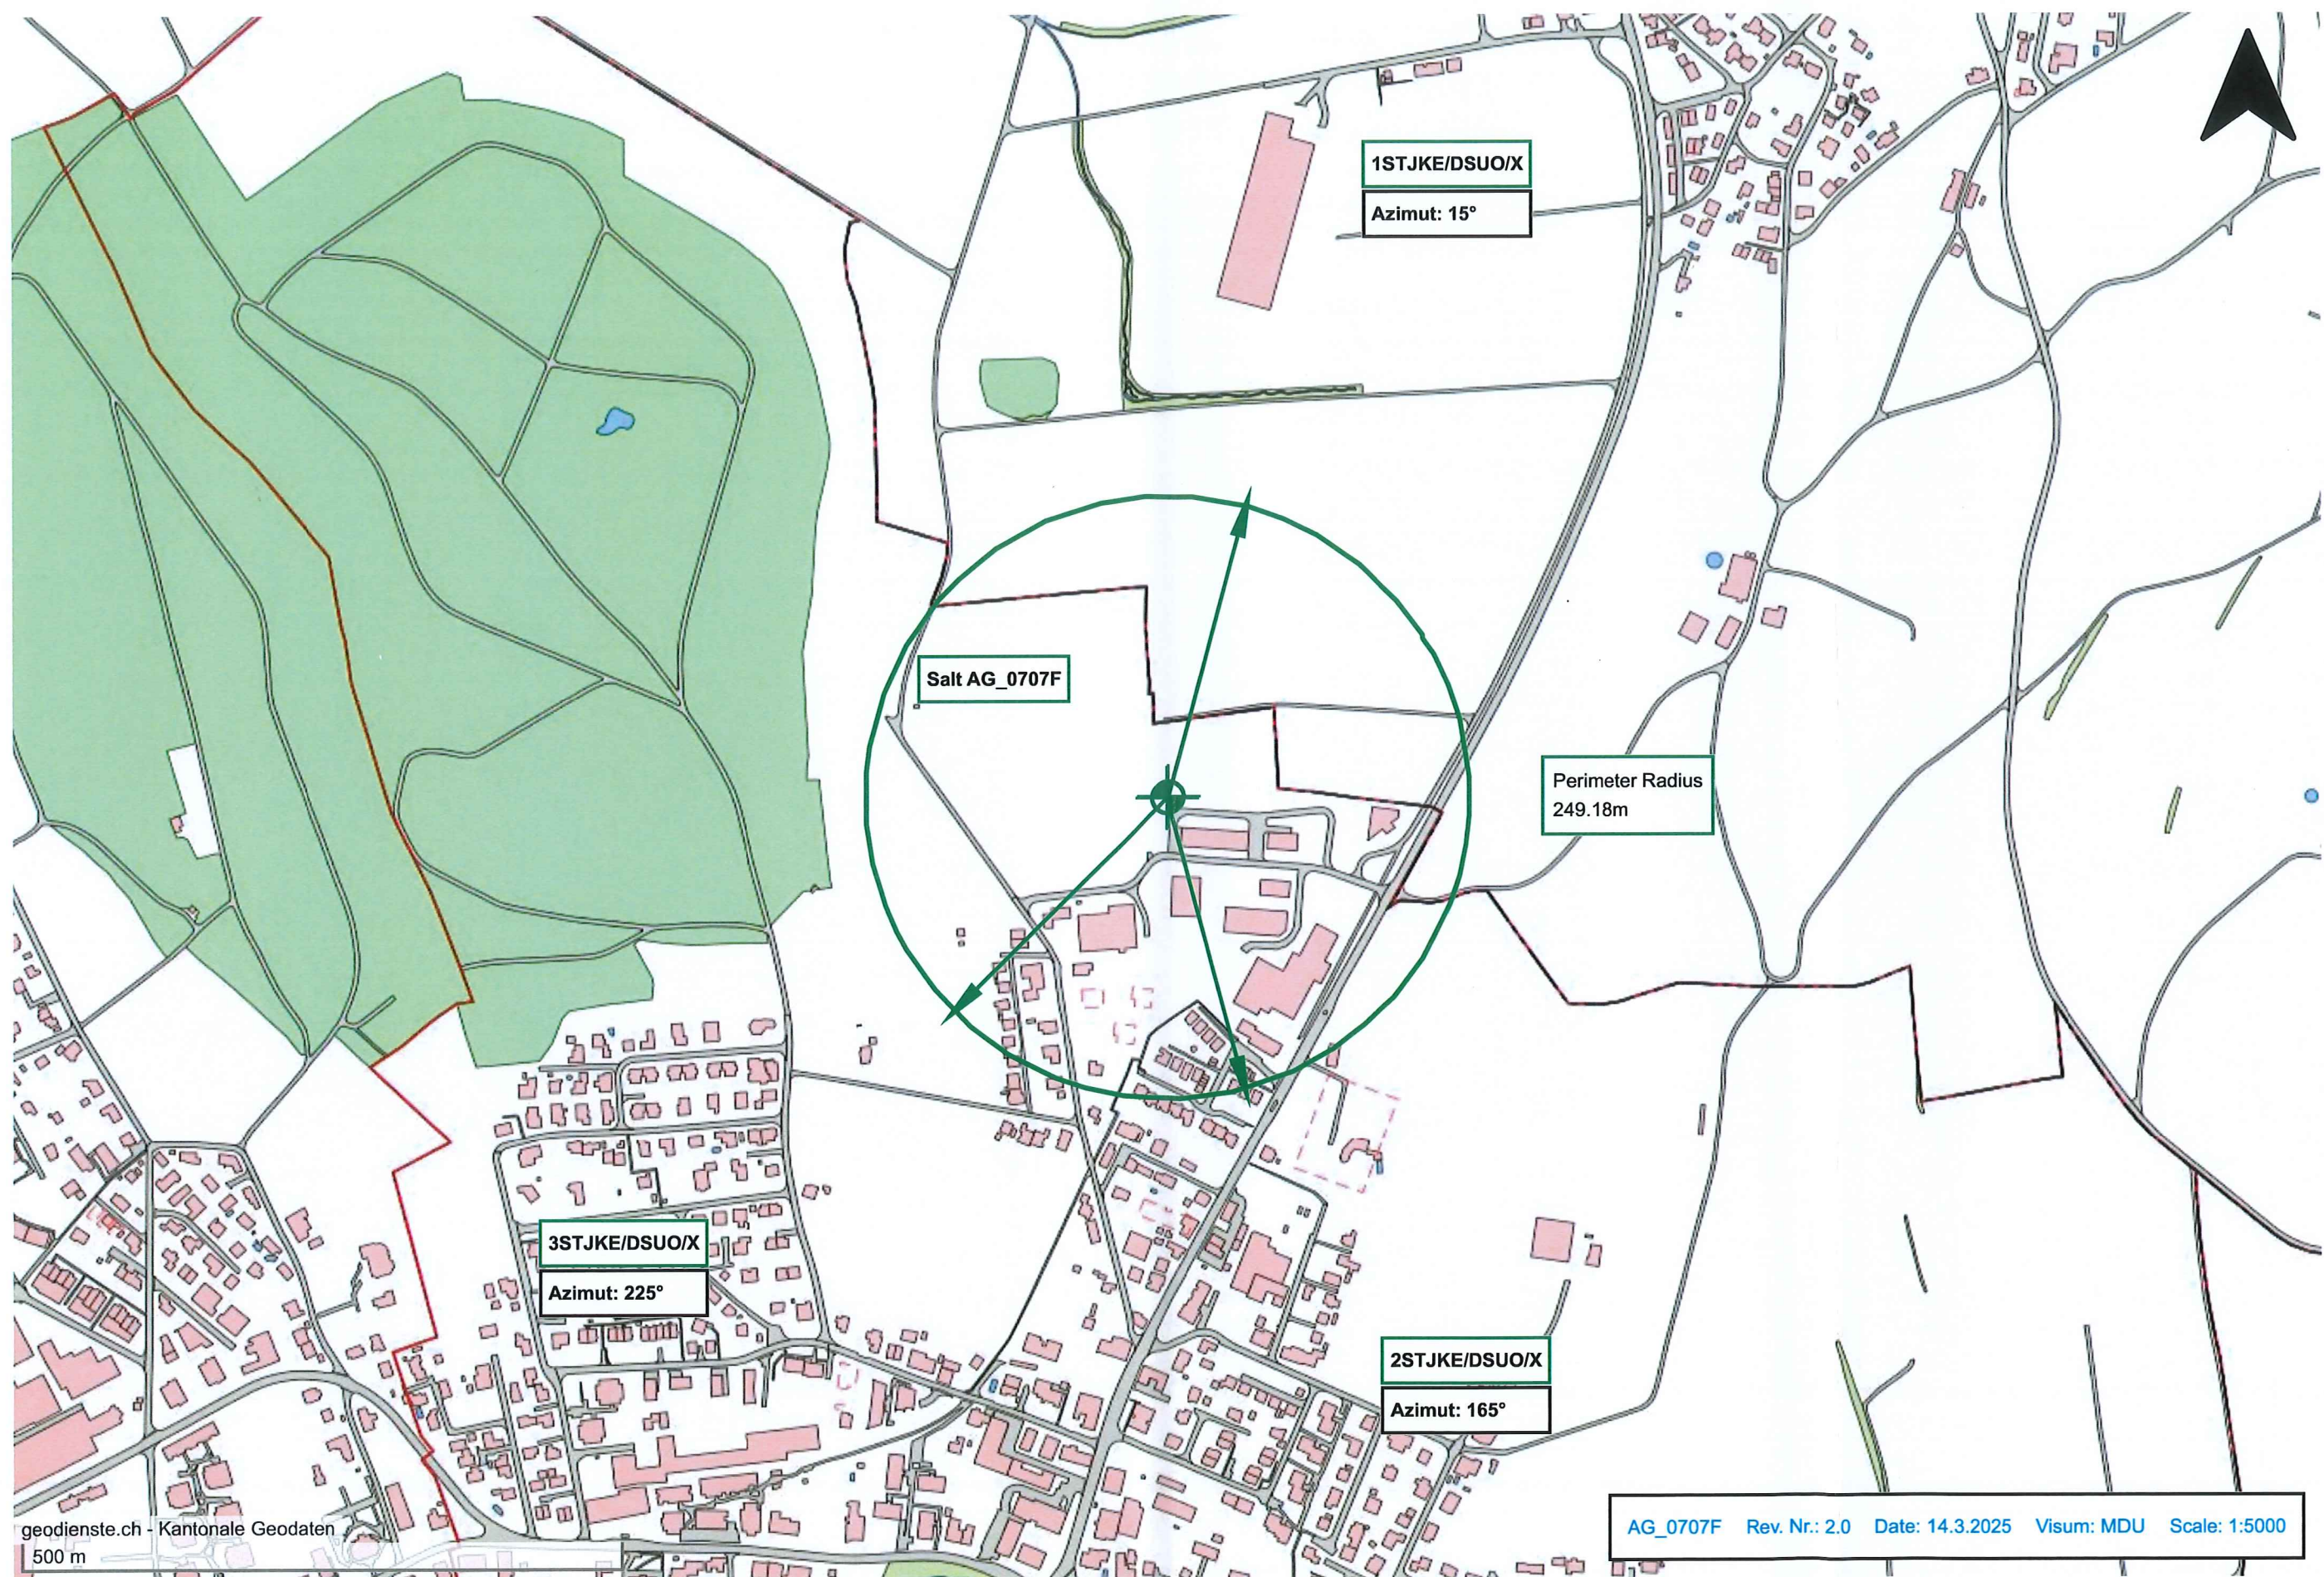


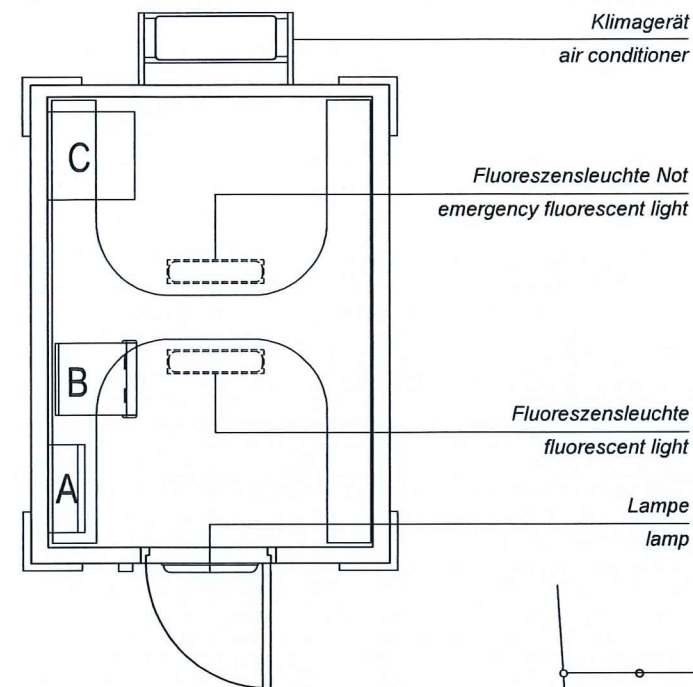


INDOORROOM LEGENDE
A Elektrokasten Typ K.1
A electrical cabinet type K.1
B Flexi Node B
C Eltek Transmission

GRUNDRISS EQUIPMENT 1:50
ROOM LAYOUT 1:50
0 0.5m 2.5m

GRUNDRISS 1:100
GROUNDPLAN 1:100
0 1m 5m

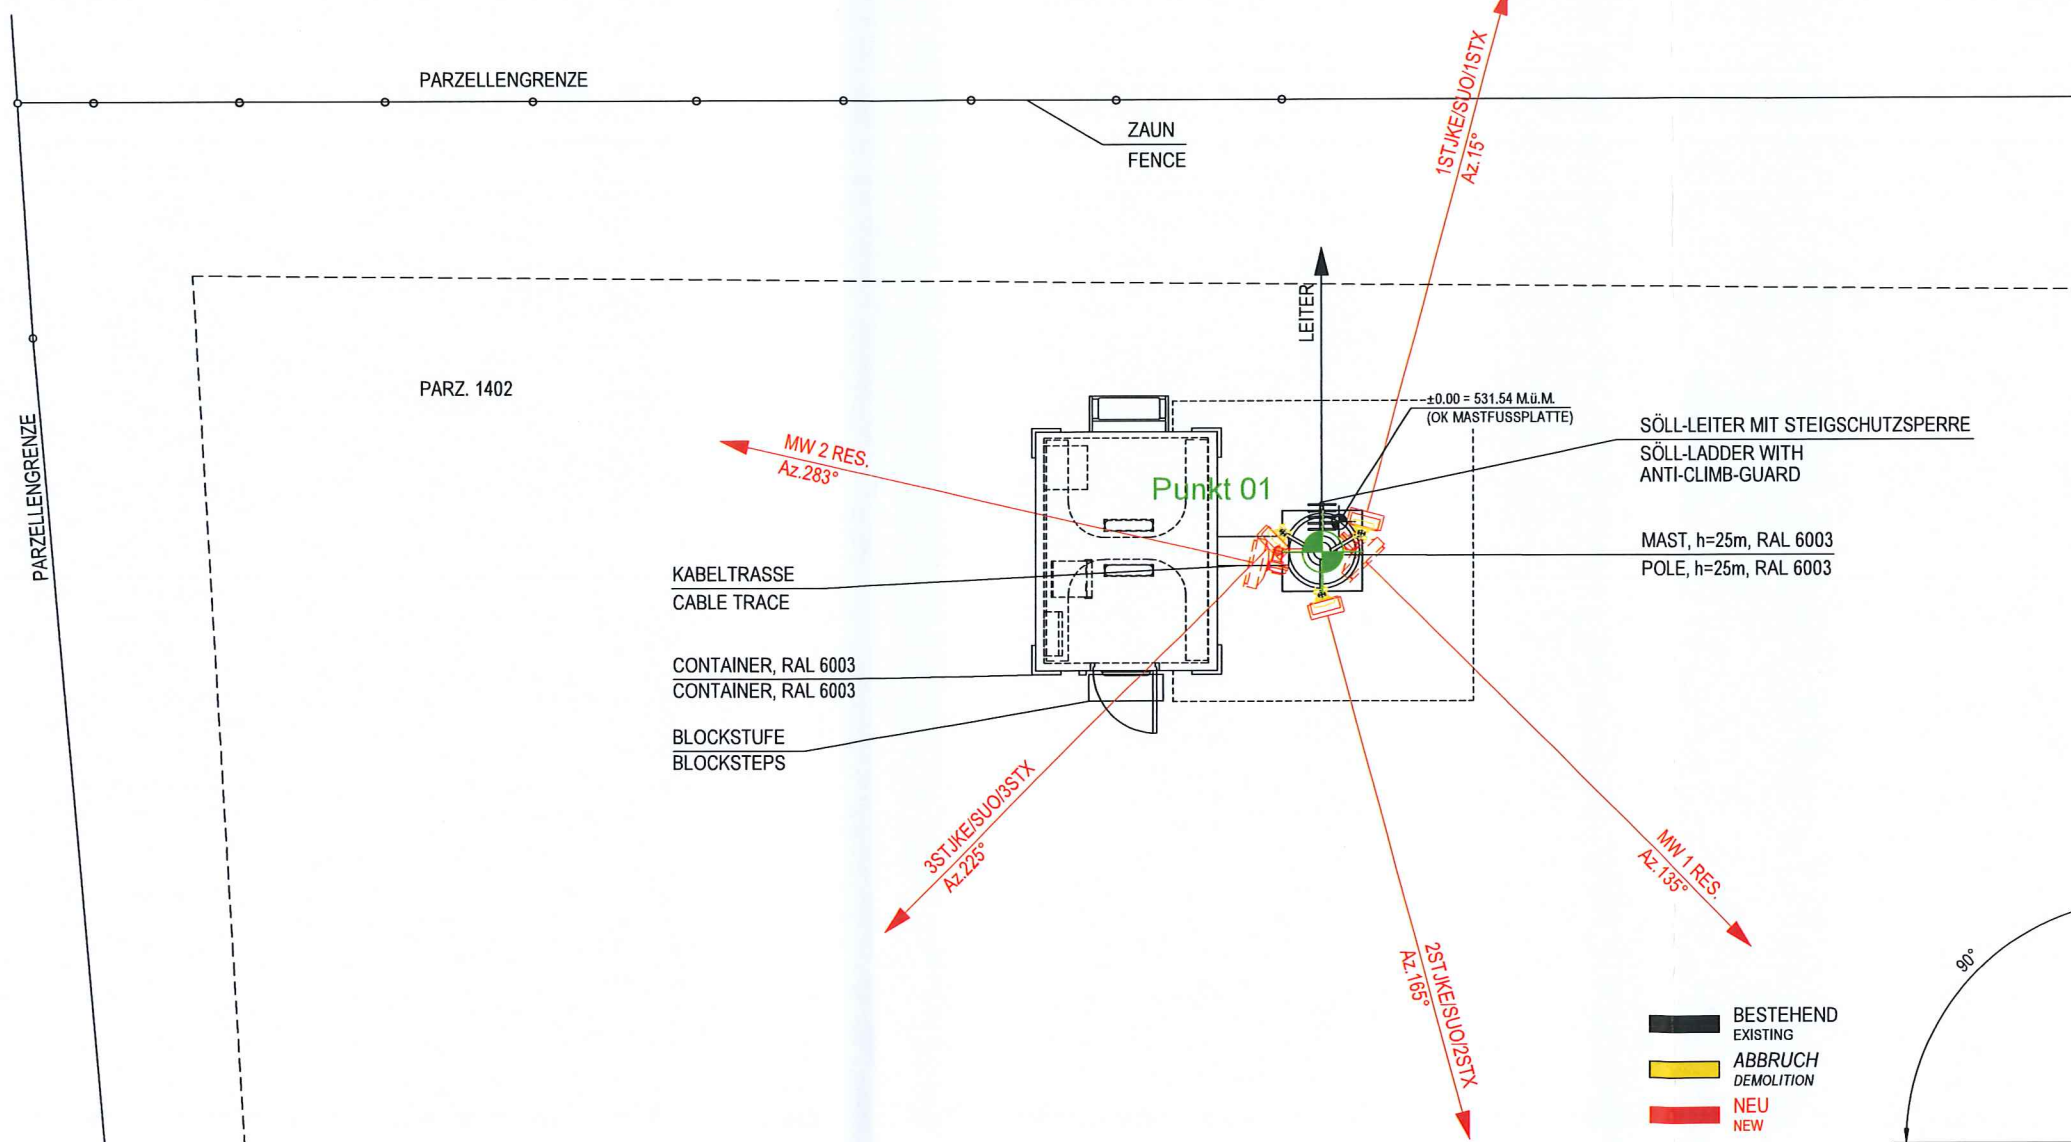

BESTEHEND
EXISTING
ABBRUCH
DEMOLITION
NEU
NEW

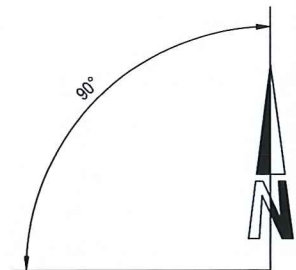

ENGINEERING BY:
tmCONCEPT AG
ENGINEERING
TM Concept AG
Delfterstrasse 12
CH-5000 Aarau
Tel. +41 62 836 42 42
Fax +41 62 836 42 32
info@tmconcept.ch


CO-LOCATION / SITE SHARING WITH:	

- ☐ GA DRAWINGS
☒ BP DRAWINGS
☐ DETAIL DRAWINGS
☐ AB DRAWINGS

REV.	DESCRIPTION	BY	DATE
REV-H			
REV-G			
REV-F			
REV-E			
REV-D			
REV-C			
REV-B			
REV-A			
SCALE	DRAWN	CHECKED + APPROVED	SITE NR.
1:100 / 1:50	M.A.	29.09.2022 NCS	29.09.2022

TITEL
TOP VIEW
FAHRWANGEN
BREITEWEG 5.1, 5615 FAHRWANGEN
PAGE 01/02

NETWORK PROVIDER:
cellnex
driving telecom connectivity
SWISS INFRA SERVICES S.A.
THURGAUERSTRASSE 136
CH-8152 OPFIKON

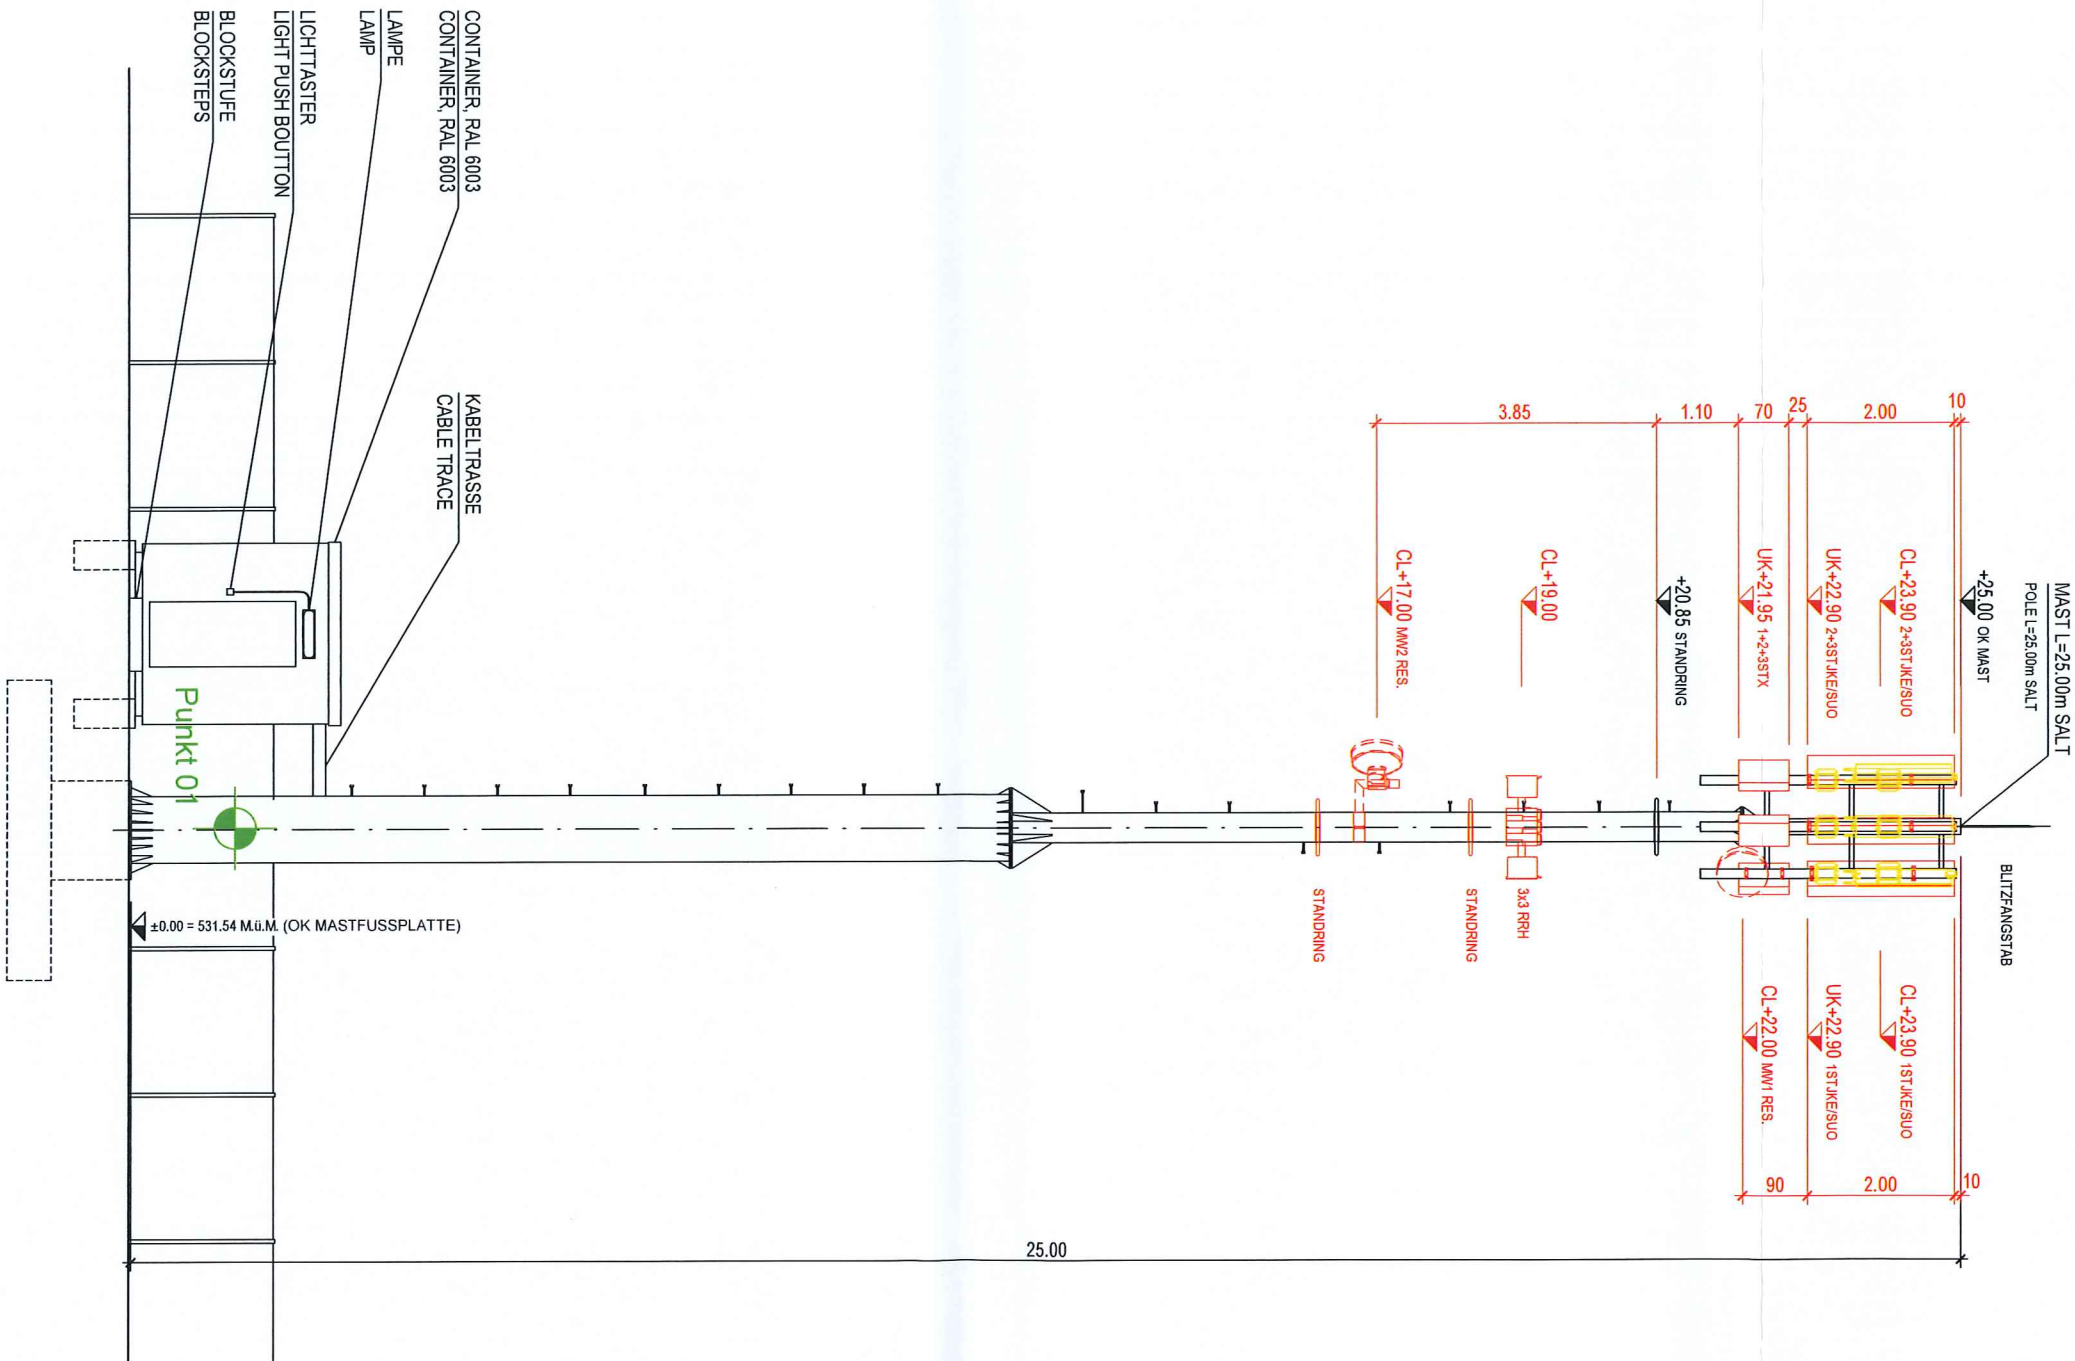

SÜDANSICHT 1:100
SOUTH VIEW 1:100

0 1m 5m

BESTEHEND
EXISTING
ABBRUCH
DEMOLITION
NEU
NEW

ENGINEERING BY:
tmCONCEPT AG
ENGINEERING

TM Concept AG
Delfterstrasse 12
CH-5000 Aarau

Tel. +41 62 836 42 42
Fax +41 62 836 42 32
info@tmconcept.ch

CO-LOCATION / SITE SHARING WITH:	

- ☐ GA DRAWINGS
- ☒ BP DRAWINGS
- ☐ DETAIL DRAWINGS
- ☐ AB DRAWINGS

REV.	DESCRIPTION	BY	DATE
REV-H			
REV-G			
REV-F			
REV-E			
REV-D			
REV-C			
REV-B			
REV-A			
SCALE	DRAWN	CHECKED + APPROVED	
1:100	M.A.	29.09.2022 NCS	29.09.2022

TITEL	
SOUTH VIEW	
FAHRWANGEN	
BREITEWEG 5.1, 5615 FAHRWANGEN	
SITE NR.	AG_0707F
PAGE	02/02

NETWORK PROVIDER:

cellnex
driving telecom connectivity

SWISS INFRA SERVICES S.A.
THURGAUERSTRASSE 136
CH-8152 OPFIKON