


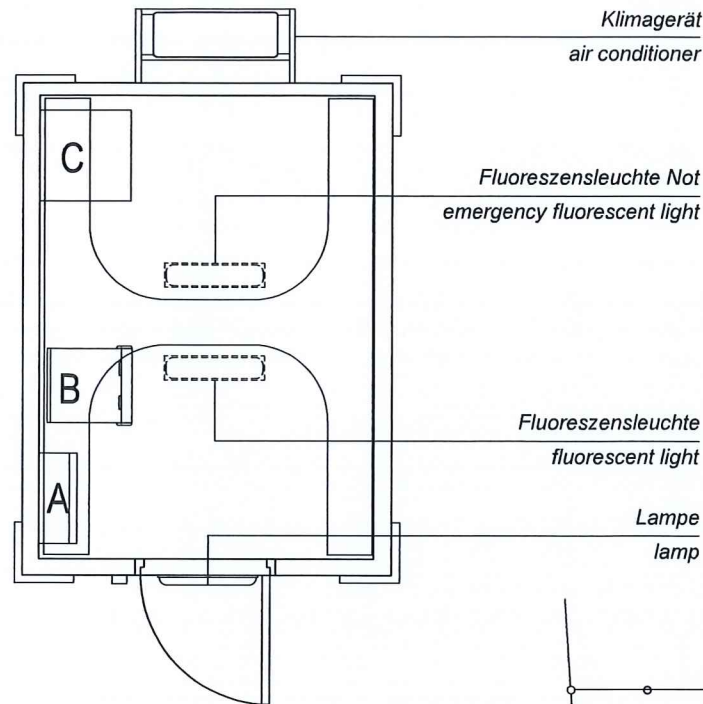

INDOORROOM LEGENDE
A Elektrokasten Typ K.1
A electrical cabinet type K.1
B Flexi Node B
C Eltek Transmision


GRUNDRISS EQUIPMENT 1:50
ROOM LAYOUT 1:50
0 0.5m 2.5m

GRUNDRISS 1:100
GROUNDPLAN 1:100
0 1m 5m

BAUHERRSCHAFT: Salt.		SALT MOBILE SA RUE DU CAUDRAY 4, 1020 RENENS	
ORT: 1020 RENENS	DATUM: 29 JAN 2024		
Radu Untaru PM Infrastructure Swiss Infra Services THURGAUERSTRASSE 136, 8152 OPFIKON			
STATIONSEIGENTÜMER: celnex		A Cellnex Telecom company	
ORT: 8152 OPFIKON	DATUM: 29 JAN 2024		
Radu Untaru PM Infrastructure Swiss Infra Services A Cellnex Telecom company			
PROJEKTVERFASSER: tmconcept		TM CONCEPT AG DELFTERSTRASSE 12, 5000 AARAU	
ORT: 5000 AARAU	DATUM: 25.01.2024		
delfterstrasse 12 5000 aarau			
EIGENTÜMER:		DATUM:	
ORT:			

SITE ID **AG_0707F**
GSM ER ID **AG_0707**
UMTS ER ID

BP-DRAW

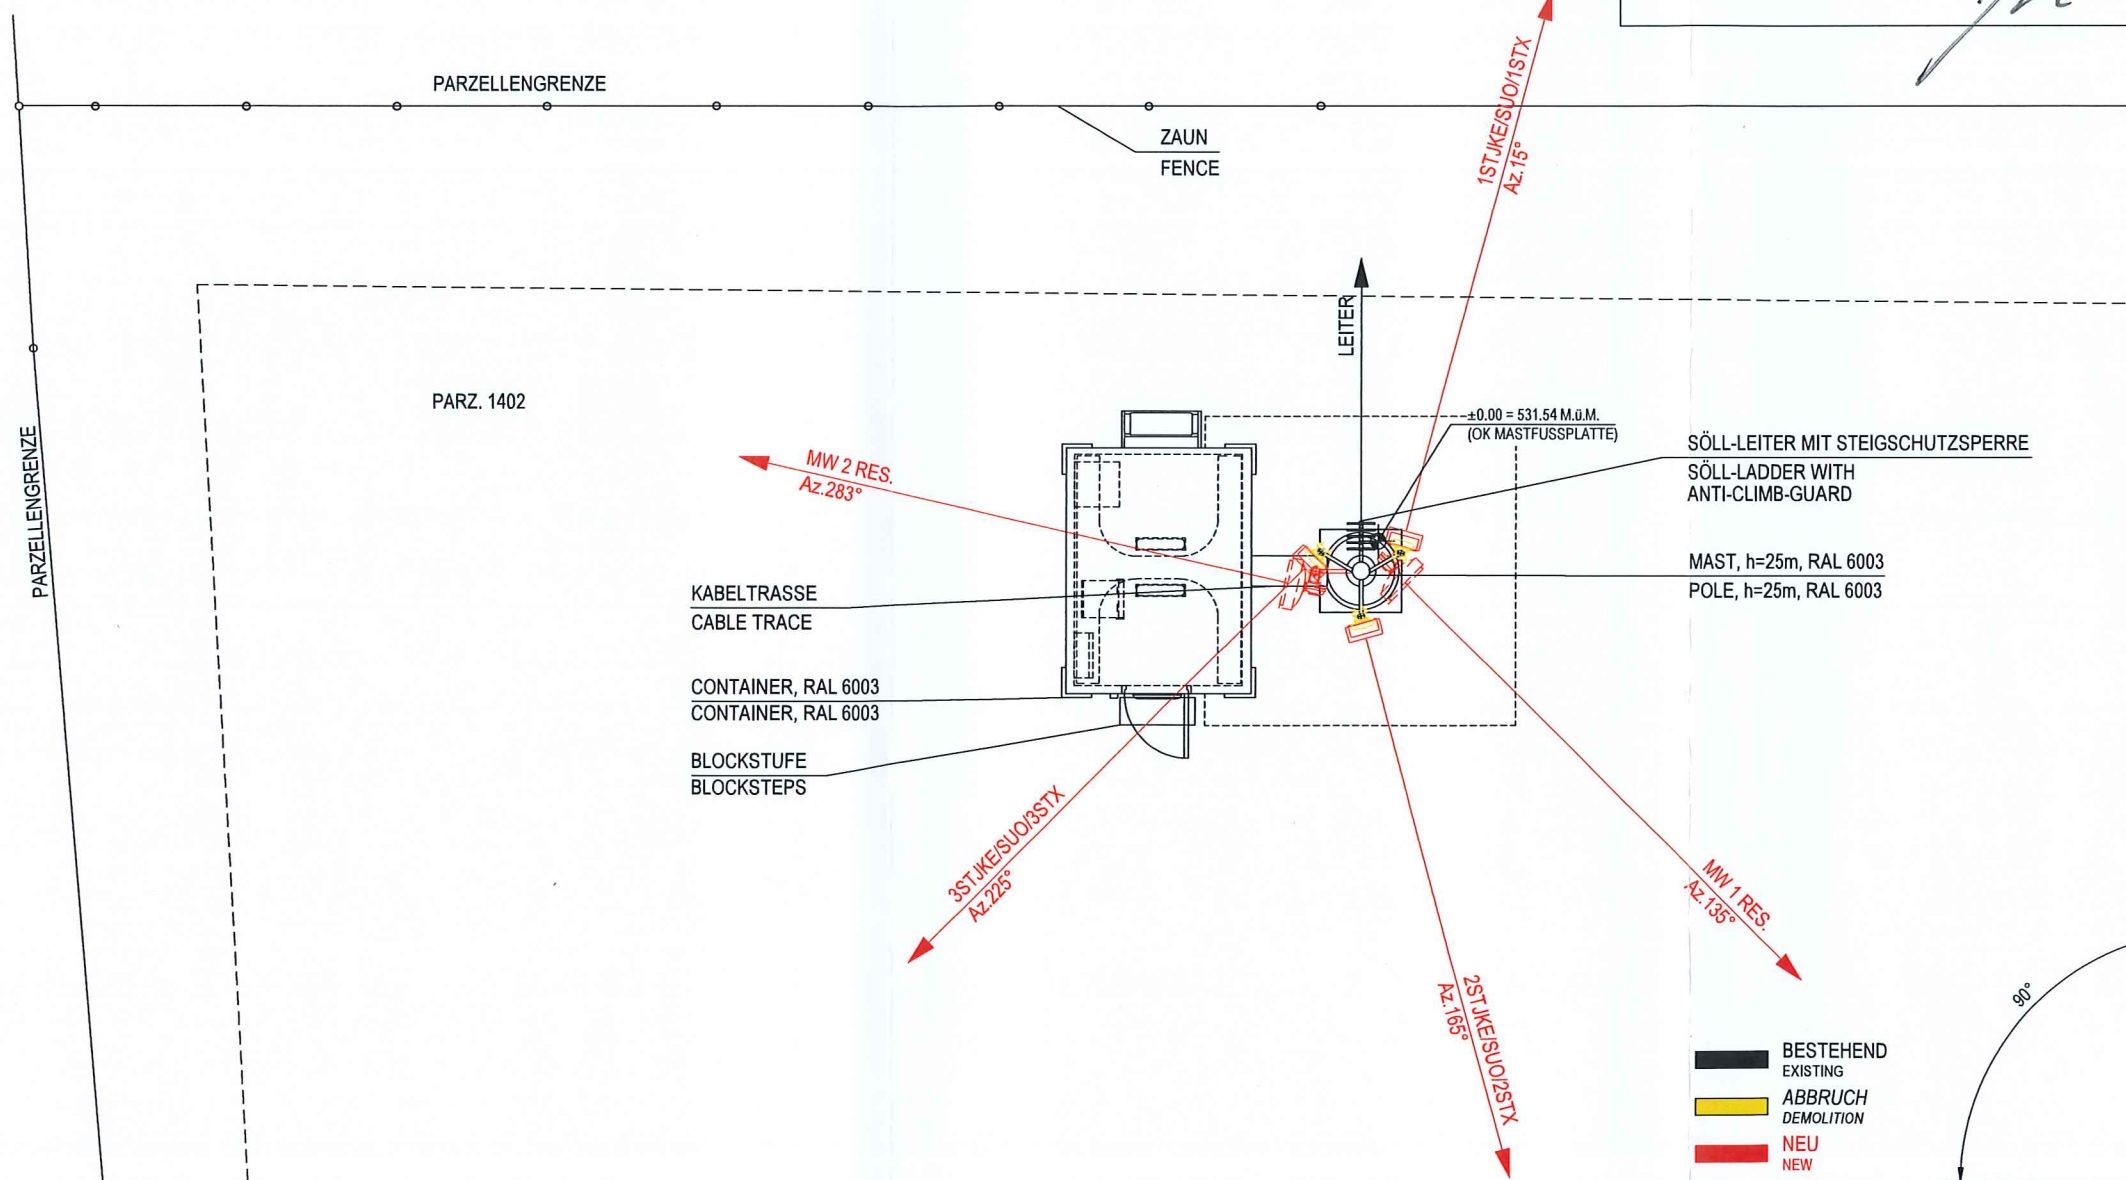

BESTEHEND
EXISTING
ABBRUCH
DEMOLITION
NEU
NEW

ENGINEERING BY:
tmconcept AG
ENGINEERING
TM Concept AG
Delfterstrasse 12
CH-5000 Aarau
Tel. +41 62 836 42 42
Fax +41 62 836 42 32
info@tmconcept.ch

CO-LOCATION / SITE SHARING WITH:	

- ☐ GA DRAWINGS
☒ BP DRAWINGS
☐ DETAIL DRAWINGS
☐ AB DRAWINGS

REV-H				
REV-G				
REV-F				
REV-E				
REV-D				
REV-C				
REV-B				
REV-A				
REV.	DESCRIPTION	BY	DATE	
SCALE	DRAWN	CHECKED + APPROVED	SITE NR.	PAGE
1:100 / 1:50	M.A.	29.09.2022 NCS	29.09.2022	

TITEL
TOP VIEW
FAHRWANGEN
BREITWEG 5.1, 5615 FAHRWANGEN
AG_0707F

NETWORK PROVIDER:
celnex
driving telecom connectivity
SWISS INFRA SERVICES S.A.
THURGAUERSTRASSE 136
CH-8152 OPFIKON

PAGE 01/02